



Elevations are for illustrative purposes only. (They are not exact scale).

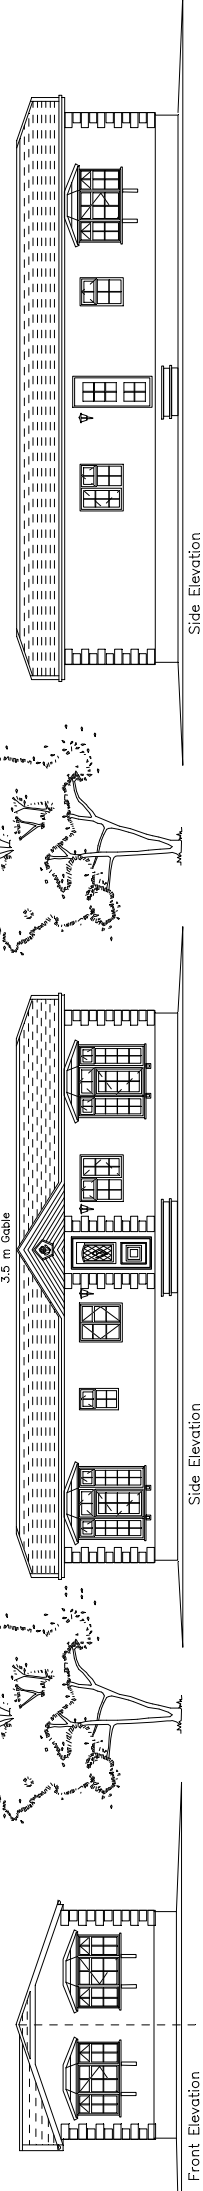

Front Elevation

Side Elevation

Side Elevation

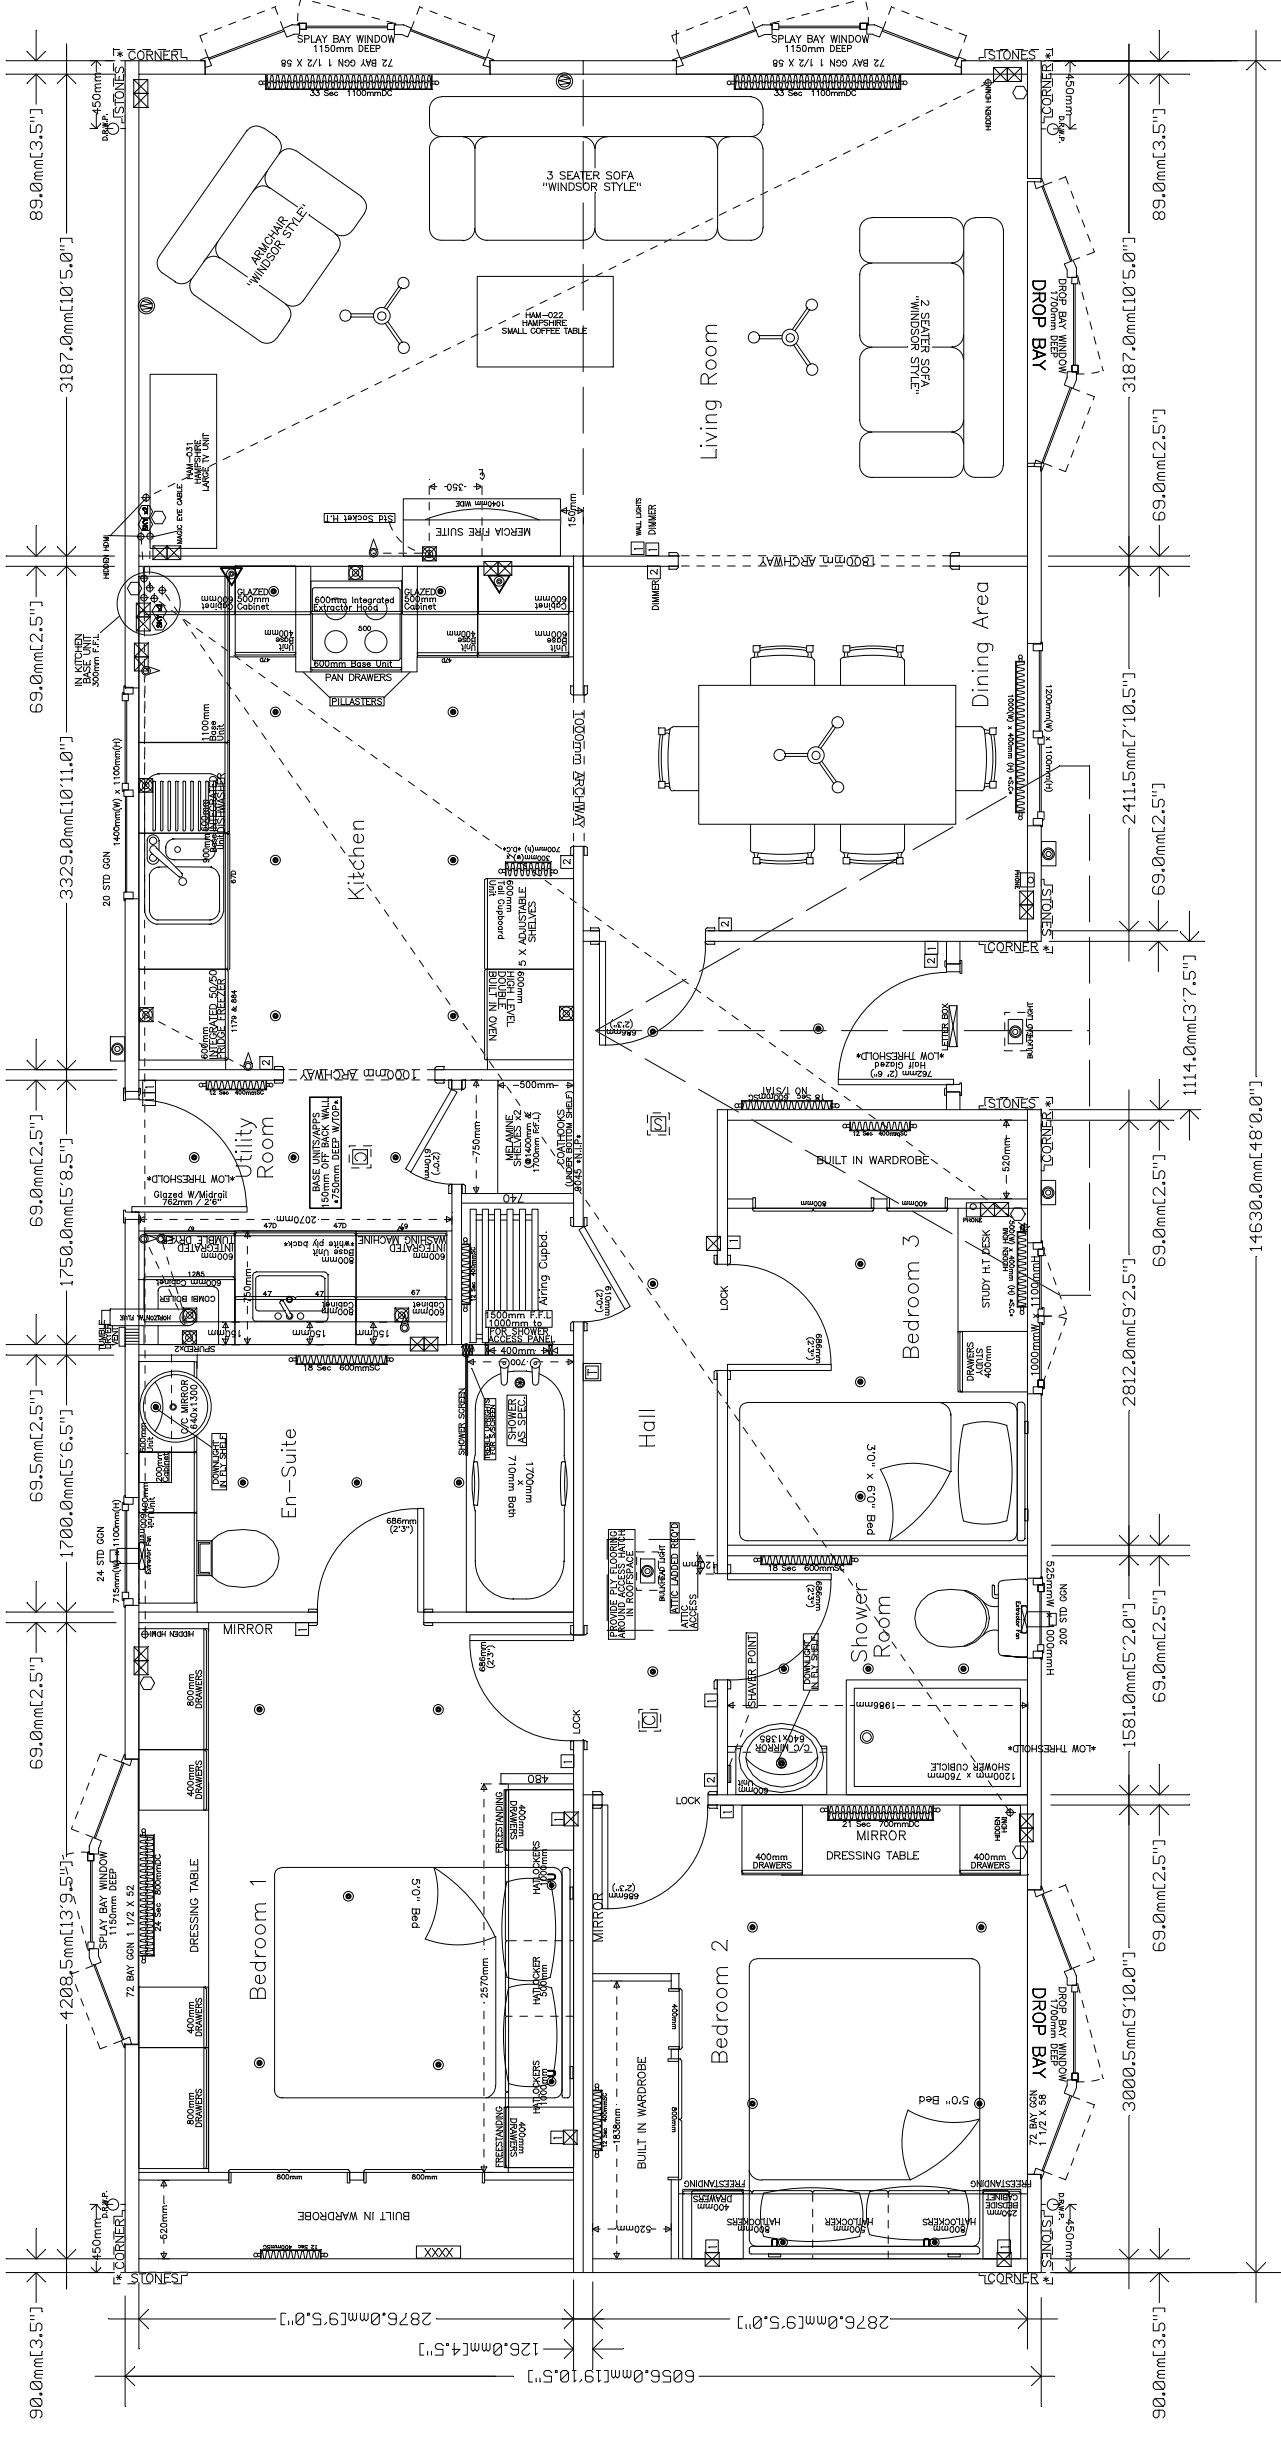

LEGEND

SYMBOL	DESCRIPTION	SYMBOL	DESCRIPTION	SYMBOL	DESCRIPTION	SYMBOL	DESCRIPTION
	Single power point		Rainwater down pipe		Light switch		D.F.W.P.
	Double power point		Extractor fan		Two-way light switch		Soil and vent pipe
	T.V. Point		Thermostat		Three-way light switch		Smoke Detector
	Sky Point		Electric meter box		METER BOX		Carbon Monoxide Detector
	Phone point back box		Consumer unit				
	Spur operable to a separate switch						

MEASUREMENTS NOTE
FOR CONSTRUCTION PURPOSES REFER TO THE DIMENSIONS IN MILLIMETRES. THE IMPERIAL DIMENSIONS ARE APPROXIMATIONS.

REVISIONS

Revised	By	Date
1	MF	17/06/2014
2	JC	02/09/2014

STALEY ALBION

TEL: 01495 244472
EMAIL: sales@staley-albion.co.uk
WEB: www.staley-albion.co.uk

DRAWING NUMBER:	17623
DRAWN BY:	MF
SCALE:	1:25 on A1/1:50 on A3
DATE:	17/06/14
ESTIMATE NUMBER:	20066
CUSTOMER NAME:	SCAMFORD PARK